


GSA#000055470
 WARD#20
 PARCEL#10642-010
 SITE PLAN#19189
 ACCT#2001043

Now or Formerly
 BOSTON TRAILER PARK, LLC
 PARCEL ID 2010637010

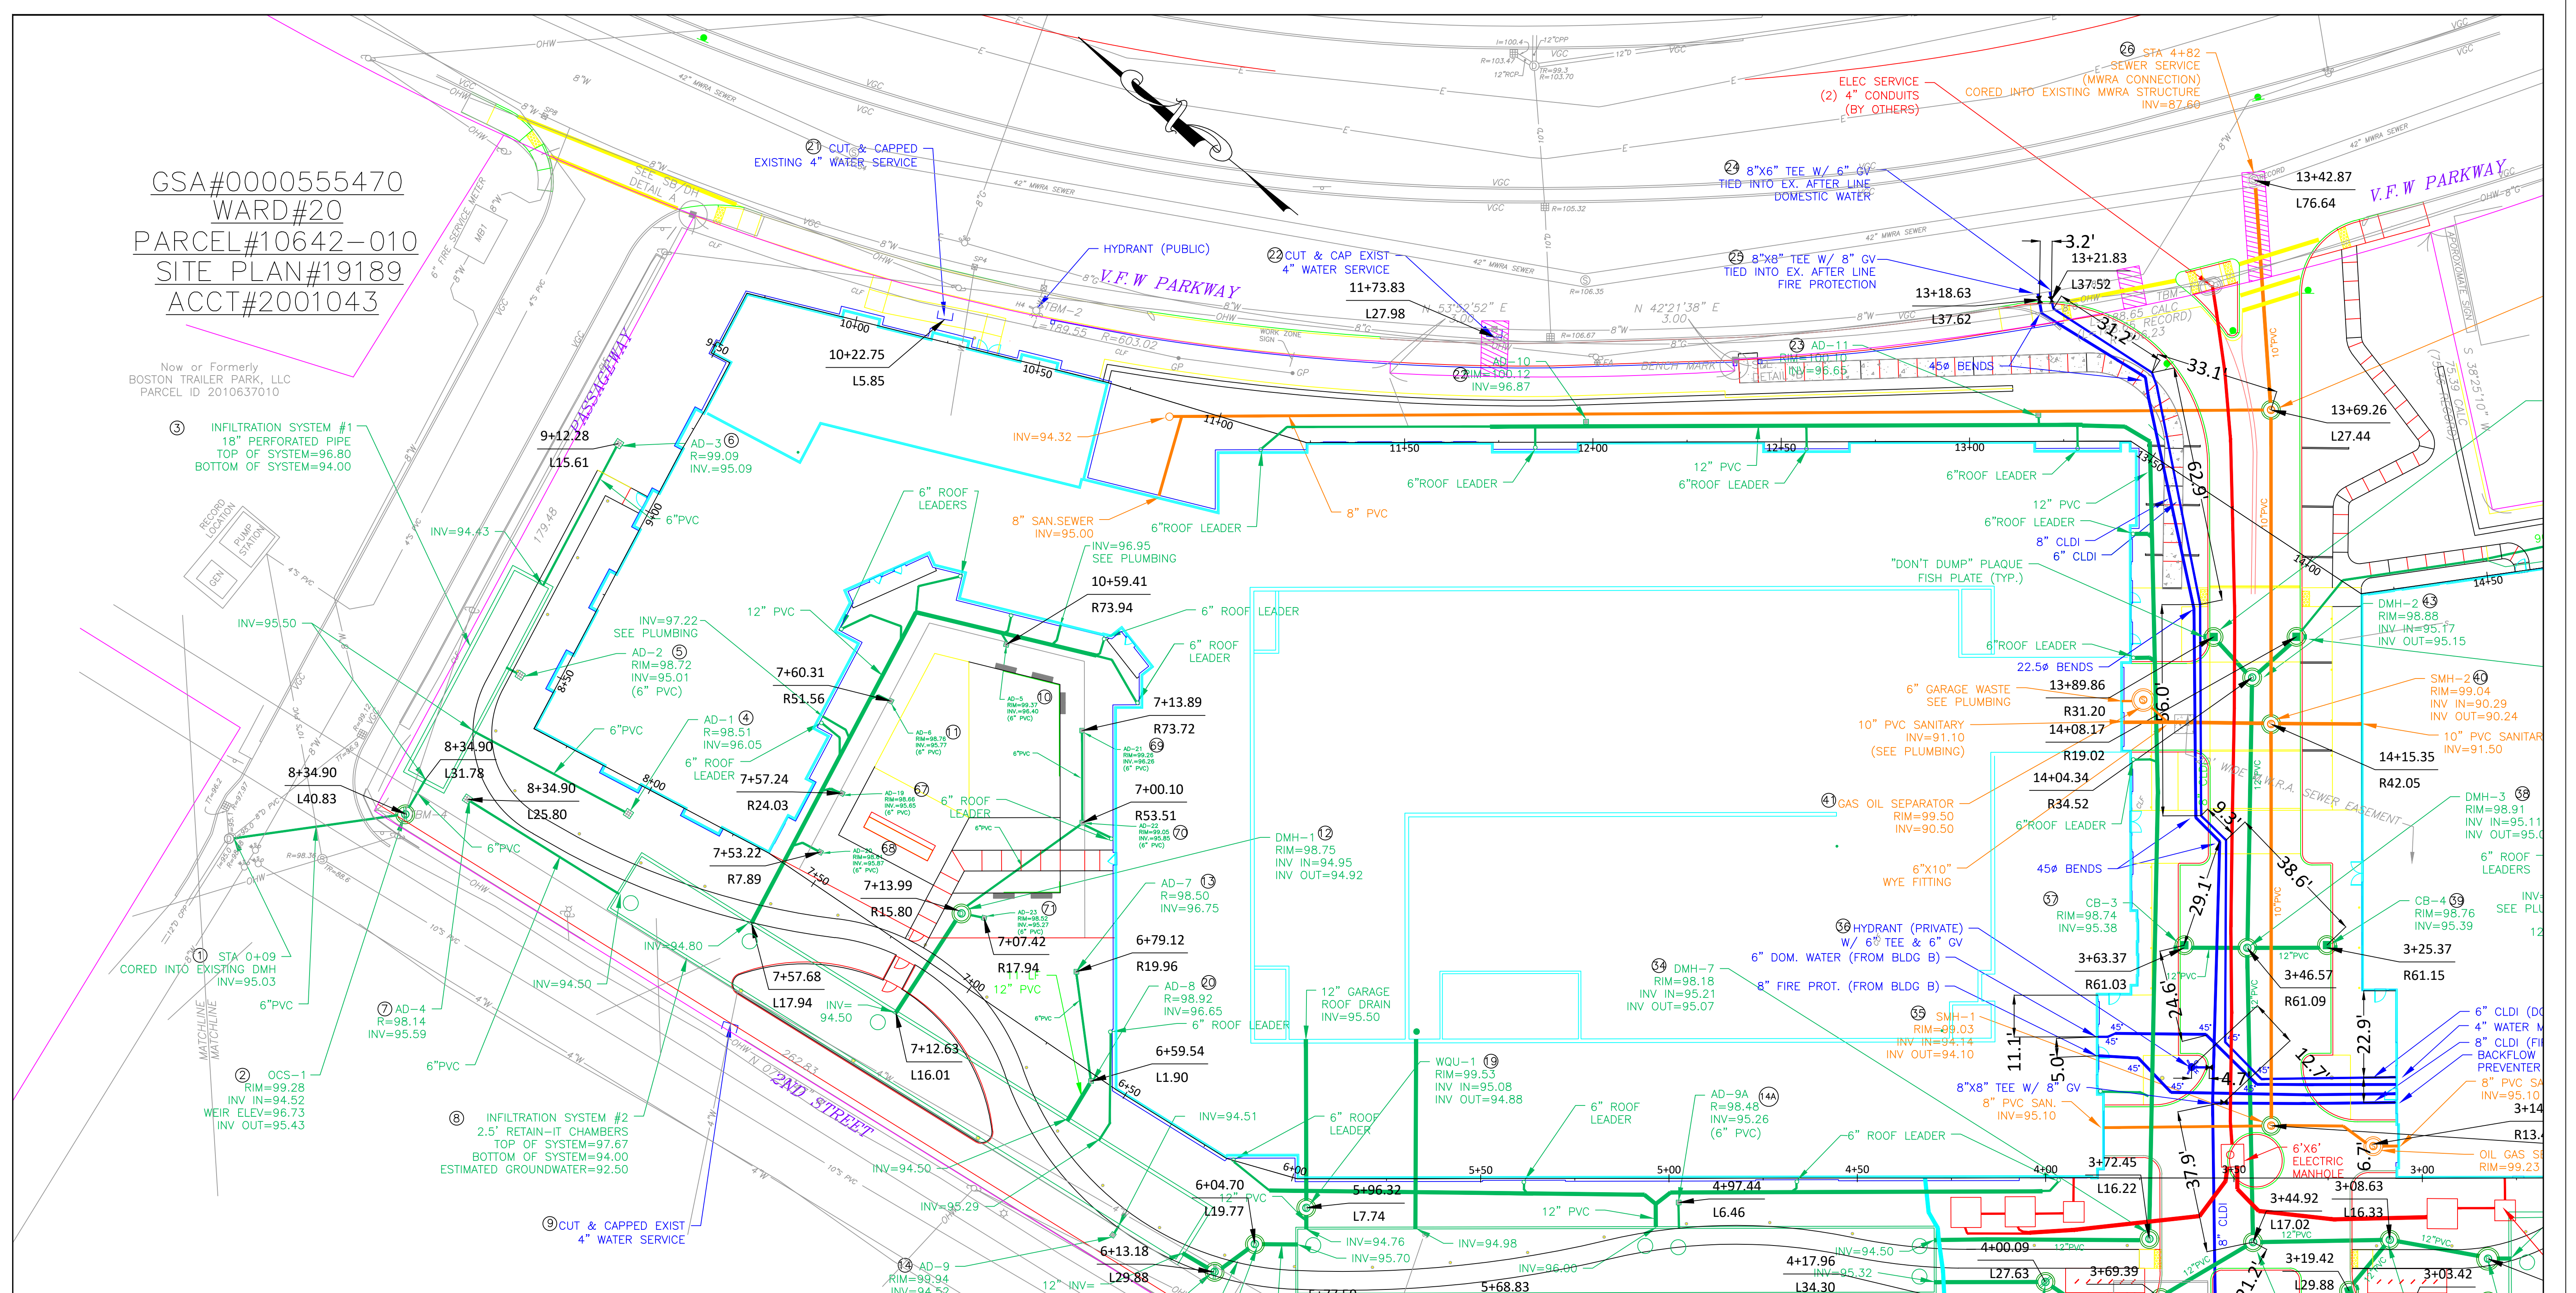


AS BUILT PLAN CERTIFICATION

I certify that these plans were prepared in accordance with the Boston Water and Sewer Commission minimum standards for As-built plans. The undersigned further certifies that the survey measurements, materials, sizes, field conditions and related utility information are based on both a field survey and/or the latest plan of record available.

Date: _____ P.E. #: _____
 Expiration Date: _____

Construction Timetable

Construction Start Date: _____ Construction Completion Date: _____

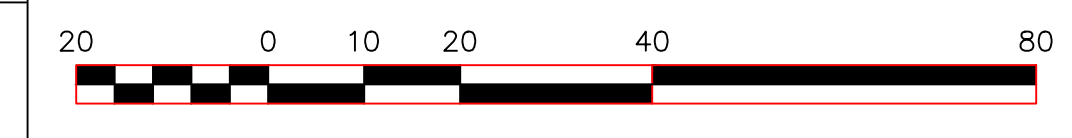

NO.	REVISIONS	BY	DATE	DES	DATE:	SCALE:
				DRN	12-16-21	1"=20'
				CHK		
				APPD		


Project Title: **VFW PARKWAY APARTMENTS**
1545-1555 VFW PARKWAY WEST ROXBURY, MA
AS-BUILT

Prepared For:
J. DERENZO COMPANY
 354 Howard Street
 Boston, Massachusetts 02102
 Ph. (508) 427 6441 Fax. (508) 427 6488

OWNER: **LINCOLN PARKWAY LLC**
1545-1555 VFW PKWAY
BOSTON, MA 02132

DECEMBER 16, 2021
 Project Mgr.: R.L.
 Superintendent: G.B.
 Survey: D.B.
 Drawn: D.B.
 Job No.: JDC: #19050
 Last Rev: _____

SHEET 1 OF 5

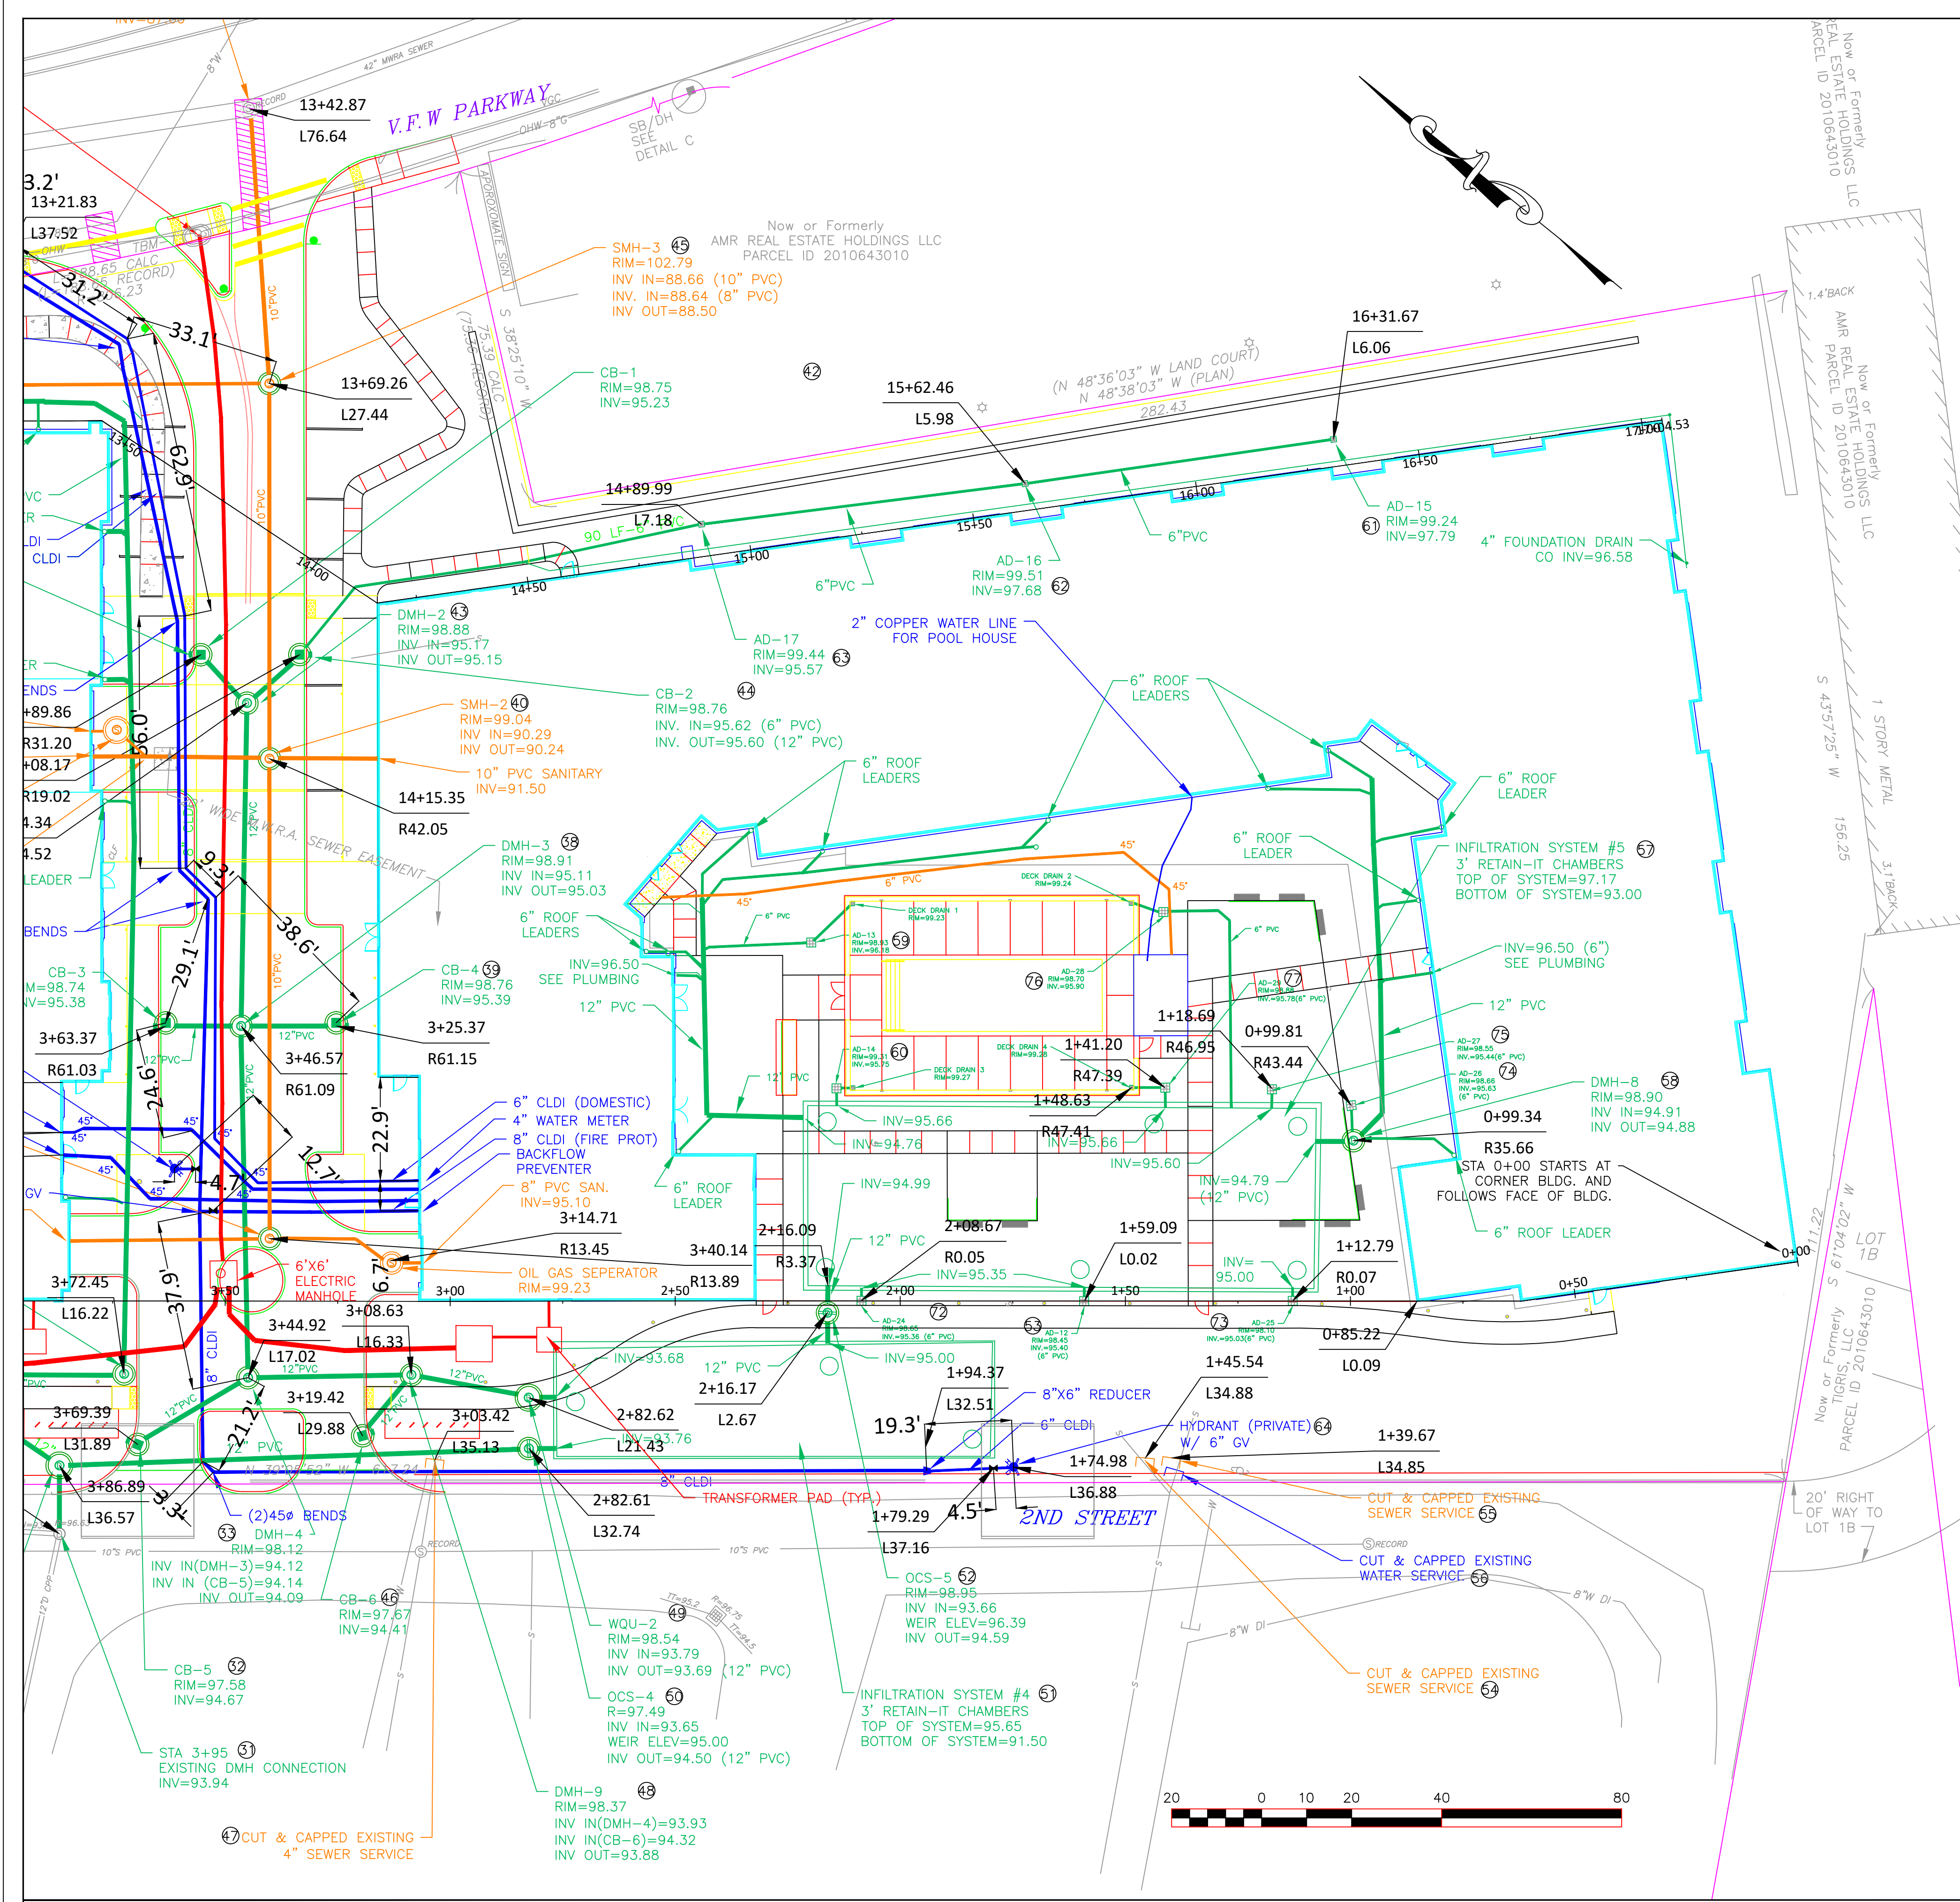

ITEM NO.	DESCRIPTION OF SERVICE	BWSC INSPECTOR/DATE	COMMENT
1	EXISTING DMH CONNECTION	R. DAVIS - 5/17/21	
2	OCS-1	M. RIVERS - 1/30/20	
3	INFILTRATION SYSTEM #1	R. PARRA - 1/21/20	
4	AD-1	T. KRABY - 11/29/21	
5	AD-2	R. MCKENNA - 3/3/20	
6	AD-3	T. KRABY - 11/29/21	
7	AD-4	T. KRABY - 11/29/21	
8	INFILTRATION SYSTEM #2	R. PARRA - 1/21/20	
9	CUT & CAP EXIST WATER SERVICE	R. PARRA - 10/7/20	
10	AD-5 (IN COURTYARD)	R. PERRY - 8/17/21	
11	AD-6 (IN COURTYARD)	R. PERRY - 8/17/21	
12	DMH-1	M. KENNEY - 2/19/20	
13	AD-7	T. KRABY - 11/29/21	
14	AD-9	R. MCKENNA - 3/3/20	
14A	AD-9A	R. MCKENNA - 12/2/21	
15	OCS-2	M. KENNEY - 2/6/20	
16	DMH-6	M. KENNEY - 2/6/20	
17	CUT & CAP EXIST SEWER SERVICE	A. ROBERTS - 1/3/20	
18	INFILTRATION SYSTEM #3	M. KENNEY - 3/13/20	
19	WQU-1	R. MCKENNA - 3/3/20	
20	AD-8	T. KRABY - 11/29/21	
21	CUT & CAP EXIST WATER SERVICE	R. PARRA - 1/8/20	
22	CUT & CAP EXIST WATER SERVICE	R. PARRA - 1/6/20	
23	AD-10	T. KRABY - 11/29/21	
24	6" DOMESTIC WATER SERVICE	R. DAVIS - 10/2/20	
25	8" FIRE PROTECTION SERVICE	R. DAVIS - 10/2/20	
26	SEWER SERVICE	R. DAVIS - 6/24/20	
27	AD-11	R. MCKENNA - 12/2/21	
28	CUT & CAP EXIST SEWER SERVICE	A. ROBERTS - 1/3/20	
29	OCS-3	M. RIVERS - 1/30/20	
30	DMH-5	M. KENNEY - 2/6/20	
31	EXIST DMH CONNECTION	M. KENNY - 2/3/20	
32	CB-5	R. PARRA - 1/14/20	
33	DMH-4	M. RIVERS - 1/13/20	
34	DMH-7	R. MCKENNA - 12/2/21	
35	SMH-1	R. PARRA - 1/14/20	
36	HYDRANT (PRIVATE)	R. PARRA - 1/22/20	
37	CB-3	G. JAMEAU - 1/7/20	
38	DMH-3	M. KENNEY - 1/27/20	
39	CB-4	R. PARRA - 1/14/20	
40	SMH-2	R. PARRA - 1/14/20	
41	GAS OIL SEPARATOR	R. DAVIS - 5/5/21	
42	CB-1 W/ CASCADE GRATE	R. PARRA - 1/21/20	
43	DMH-2	M. KENNEY - 2/6/20	
44	CB-2 W/ CASCADE GRATE	R. PARRA - 1/21/20	
45	SMH-3	G. JAMEAU - 1/7/20	
46	CB-6	R. PARRA - 1/14/20	
47	CUT & CAP EXIST SEWER SERVICE	A. ROBERTS - 1/3/20	
48	DMH-9	M. RIVERS - 1/13/20	
49	WQU-2	R. MCKENNA - 3/3/20	
50	OCS-4	M. KENNY - 2/3/20	
51	INFILTRATION SYSTEM #4	M. KENNEY - 1/27/20	
52	OSC-5	M. KENNY - 2/3/20	
53	AD-12 (IN COURTYARD)	R. MCKENNA - 3/3/20	
54	CUT & CAP EXIST SEWER SERVICE	A. ROBERTS - 1/3/20	
55	CUT & CAP EXIST SEWER SERVICE	A. ROBERTS - 1/3/20	
56	CUT & CAP EXIST WATER SERVICE	R. PARRA - 1/6/20	
57	INFILTRATION SYSTEM #5	M. KENNEY - 2/19/20	
58	DMH-8	R. DAVIS - 5/17/21	
59	AD-13 (IN COURTYARD)	R. DAVIS - 5/17/21	
60	AD-14 (IN COURTYARD)	R. MCKENNA - 3/3/20	
61	AD-15	T. KRABY - 11/29/21	
62	AD-16	T. KRABY - 11/29/21	
63	AD-17	T. KRABY - 11/29/21	
64	HYDRANT (PRIVATE)	M. KENNEY - 2/6/20	
65	INSPECT OIL GAS SEPARATOR	T. KRABY - 11/29/21	
66	INSPECT OIL GAS SEPARATOR	T. KRABY - 11/29/21	
67	AD#19	R. PERRY - 8/17/21	
68	AD#20	R. PERRY - 8/17/21	
69	AD#21	R. PERRY - 8/17/21	
70	AD#22	R. PERRY - 8/17/21	
71	AD#23	R. MCKENNA - 3/3/20	
72	AD#24	R. MCKENNA - 3/3/20	
73	AD#25	R. MCKENNA - 3/3/20	
74	AD#26	R. DAVIS - 5/17/21	
75	AD#27	R. MCKENNA - 3/3/20	
76	AD#28	R. DAVIS - 5/17/21	
77	AD#29	R. MCKENNA - 3/3/20	
"DON'T DUMP" PLAQUE (6)			
AS-BUILT			
4:1 1/1			

GSA#0000555470
 WARD#20
 PARCEL#10642-010
 SITE PLAN#19189
 ACCT#2001043

NO.	REVISIONS	BY	DATE	DES

DATE: 12-16-21
 SCALE: 1"=20'

Project Title: **VFW PARKWAY APARTMENTS**
 1545-1555 VFW PARKWAY WEST ROXBURY, MA
 AS-BUILT

Prepared For: **J. Derenzo Company**
 354 Howard Street
 Brockton, Massachusetts 02302
 Ph: (508) 427 6441 Fax: (508) 427 6488

OWNER: **LINCOLN PARKWAY LLC**
 1545-1555 VFW PKWAY
 BOSTON, MA 02132

DECEMBER 16, 2021
 Project Mgr.: R.L.
 Superintendent: G.B.
 Survey: D.B.
 Drawn: D.B.
 Job No.: JDC: #19050
 Last Rev:

SHEET 2 OF 5